

UTILITY LEGEND

SS	PROPOSED SANITARY SEWER WITH CLAY CONTAINMENT
WR	PROPOSED WATER LINE WITH CLAY CONTAINMENT
SS	EXISTING SANITARY SEWER
ST	EXISTING WATER LINE
SS	STORM PIPE (<10" NEW)
SS	STORM PIPE (>12" NEW)
SS	MAJOR CONTOUR (NEW)
SS	MINOR CONTOUR (NEW)
SS	STEEL CASING

Exhibit 2 to AIS

CAUTION !!
GAS IN THE AREA


RECORD DRAWINGS:

THE INTENT OF THE OWNER AND ENGINEER WAS TO CONSTRUCT THE FACILITIES ACCORDING TO THESE PLANS AS APPROVED BY THE CITY OF DENTON. THE OWNER OR ENGINEER DID NOT VERIFY LINES OR GRADES AFTER CONSTRUCTION AND IS NOT AWARE OF ANY CHANGES OR REVISIONS TO THESE PLANS DURING CONSTRUCTION EXCEPT AS NOTED BASED ON INFORMATION PROVIDED BY: ST. ANDREWS ENVIRONMENTAL FUEL SYSTEMS, INC. PHONE: (817) 401-3545 CONTACT: RANDY PAINTER


NOTES:

- 1) THE CITY IS RESPONSIBLE FOR THE CONSTRUCTION COST OF:
 - A) THE REMOVAL OF THE EXISTING MANHOLE AT STATION 15+25.25 LINE "SS-1"
 - B) THE INSTALLATION OF THE NEW 10" SANITARY SEWER LINE BETWEEN STATIONS 15+25.25 AND 14+77.82 LINE "SS-1"
- 2) TAPS MADE TO EXISTING SEWER LINES SHALL BE DONE BY THE CONTRACTOR AT THEIR OWN RISK. THE CONTRACTOR SHALL MAINTAIN CONTACT WITH THE WASTEWATER DEPARTMENT AT 940-348-8489
- 3) 2" CLAY CONTAINMENT IS REQUIRED ON ALL EXISTING SANITARY SEWER LINES SEE SHEETS 9 AND 10

- UTILITY GENERAL NOTES CONTINUED:
1. THE CONTRACTOR SHALL CONNECT WATER AND SANITARY SEWER SERVICES TO BUILDING PLUMBING WITHIN 5 FEET OF THE BUILDING.
 2. ALL SANITARY SEWER AND WATER SERVICES SHALL BE INSTALLED IN ACCORDANCE WITH THE CITY OF DENTON STANDARDS.
 3. THE CONTRACTOR SHALL OBTAIN ALL NECESSARY PERMITS FROM THE CITY OF DENTON PERMITS DEPARTMENT PRIOR TO STARTING CONSTRUCTION.
 4. FIRE HYDRANTS SHALL MEET THE CITY OF DENTON FIRE DEPT. STANDARDS AND SHALL BE PAINTED RED.
 5. CONTRACTOR TO ADJUST TOPS OF ALL MANHOLES TO MATCH FINISHED GRADE.
 6. ALL WATER AND SANITARY SEWER MAINS SHALL HAVE A 10 FOOT LATERAL SEPARATION.

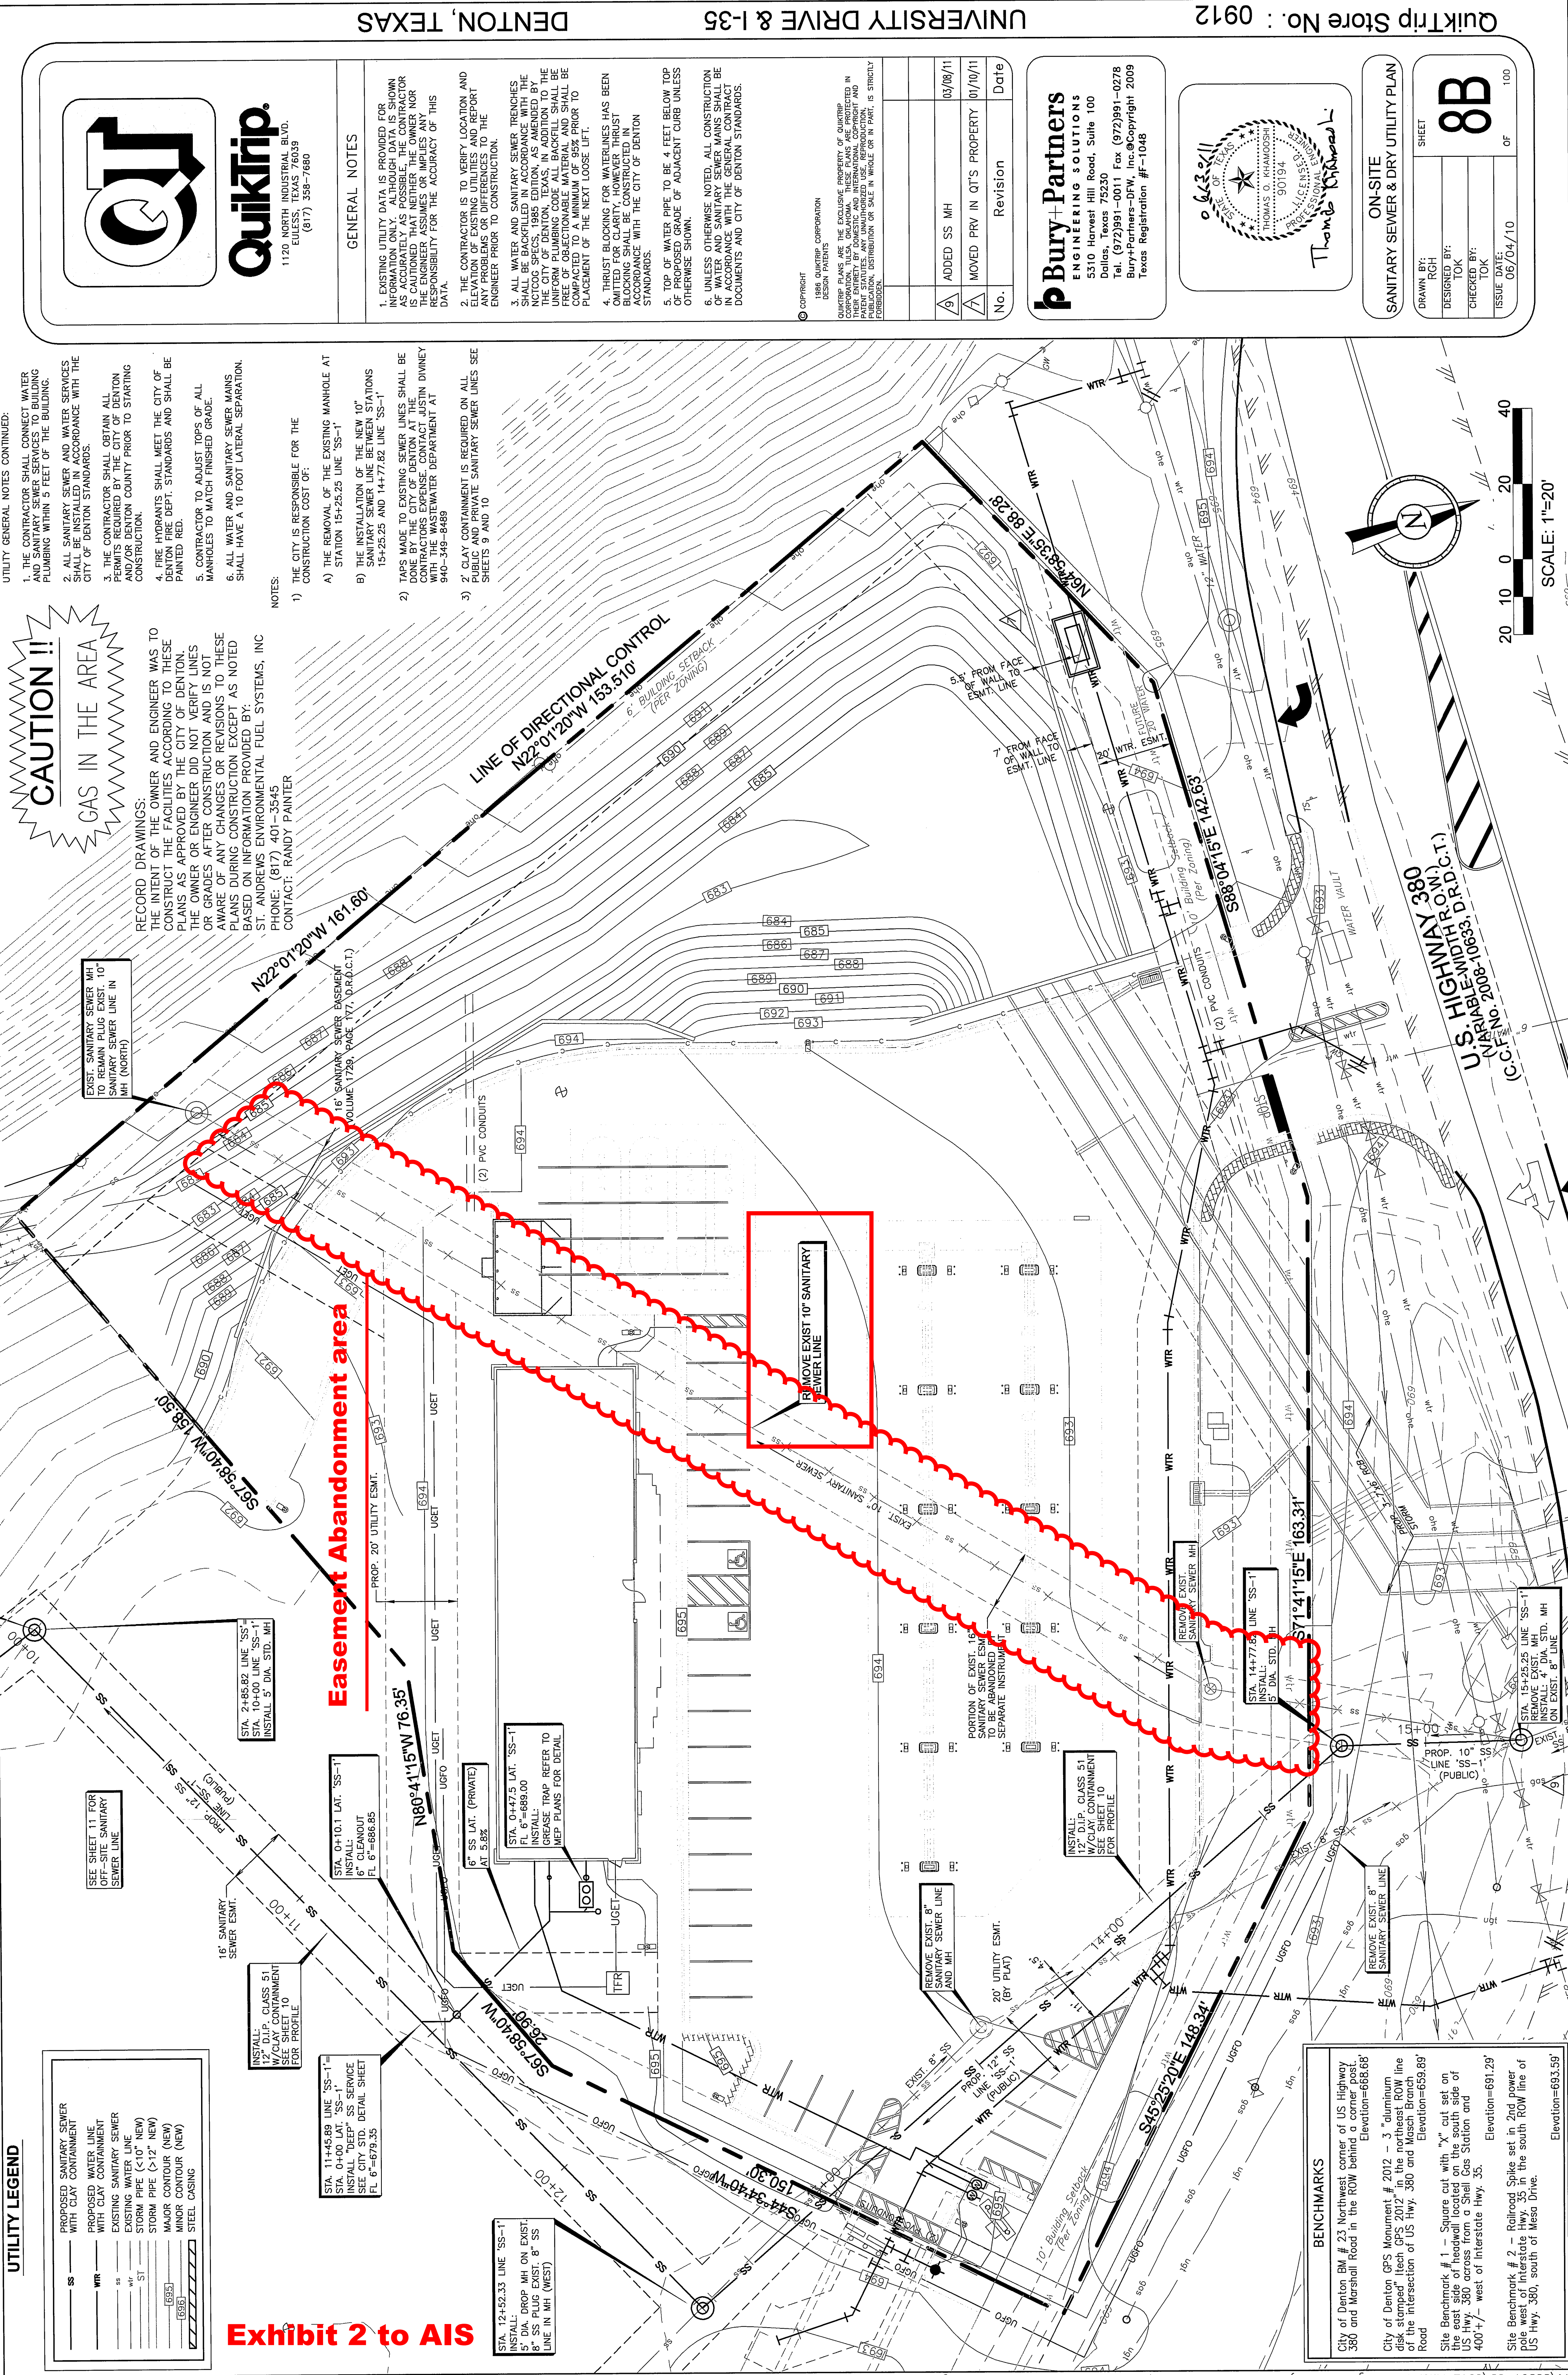

- UTILITY GENERAL NOTES CONTINUED:
1. THE CONTRACTOR SHALL CONNECT WATER AND SANITARY SEWER SERVICES TO BUILDING PLUMBING WITHIN 5 FEET OF THE BUILDING.
 2. ALL SANITARY SEWER AND WATER SERVICES SHALL BE INSTALLED IN ACCORDANCE WITH THE CITY OF DENTON STANDARDS.
 3. THE CONTRACTOR SHALL OBTAIN ALL NECESSARY PERMITS FROM THE CITY OF DENTON PERMITS DEPARTMENT PRIOR TO STARTING CONSTRUCTION.
 4. FIRE HYDRANTS SHALL MEET THE CITY OF DENTON FIRE DEPT. STANDARDS AND SHALL BE PAINTED RED.
 5. CONTRACTOR TO ADJUST TOPS OF ALL MANHOLES TO MATCH FINISHED GRADE.
 6. ALL WATER AND SANITARY SEWER MAINS SHALL HAVE A 10 FOOT LATERAL SEPARATION.

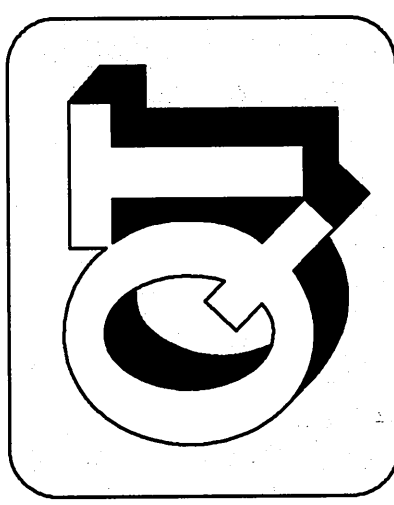

QuikTrip.
1120 NORTH INDUSTRIAL BLVD.
EDGEMOND, TEXAS 76039
(817) 358-7680

GENERAL NOTES


1. EXISTING UTILITY DATA IS PROVIDED FOR INFORMATION ONLY. ALTHOUGH DATA IS SHOWN AS ACCURATELY AS POSSIBLE, THE CONTRACTOR IS CAUTIONED THAT NEITHER THE ENGINEER NOR THE CITY OF DENTON ASSUMES ANY LIABILITY OR RESPONSIBILITY FOR THE ACCURACY OF THIS DATA.
2. THE CONTRACTOR IS TO VERIFY LOCATION AND ELEVATION OF EXISTING UTILITIES AND REPORT ANY PROBLEMS OR DIFFERENCES TO THE ENGINEER PRIOR TO CONSTRUCTION.
3. ALL WATER AND SANITARY SEWER TRENCHES SHALL BE BACKFILLED IN ACCORDANCE WITH THE NCTCOG SPECS, 1985 EDITION, AS AMENDED BY THE CITY OF DENTON, TEXAS, IN ADDITION TO THE UNIFORM PLUMBING CODE ALL BACKFILL SHALL BE COMPACTED TO A MINIMUM OF 95% PRIOR TO PLACEMENT OF THE NEXT LOOSE LIFT.
4. THRUST BLOCKING FOR WATERLINES HAS BEEN REQUIRED FOR ALL EXISTING AND PROPOSED WATERLINES. THRUST BLOCKING SHALL BE CONSTRUCTED IN ACCORDANCE WITH THE CITY OF DENTON STANDARDS.
5. TOP OF WATER PIPE TO BE 4 FEET BELOW TOP OF PROPOSED GRADE OF ADJACENT CURB UNLESS OTHERWISE SHOWN.
6. UNLESS OTHERWISE NOTED, ALL CONSTRUCTION SHALL BE IN ACCORDANCE WITH THE CITY OF DENTON STANDARDS. THE GENERAL CONTRACTOR SHALL BE RESPONSIBLE FOR THE GENERAL CONTRACT DOCUMENTS AND CITY OF DENTON STANDARDS.

© COPYRIGHT
1986 QUICKTRIP CORPORATION
DESIGN PATENTS

QUICKTRIP PLANS ARE THE EXCLUSIVE PROPERTY OF QUICKTRIP CORPORATION AND ARE NOT TO BE REPRODUCED, COPIED, OR TRANSMITTED IN ANY FORM OR BY ANY MEANS, ELECTRONIC OR MECHANICAL, INCLUDING PHOTOCOPYING, RECORDING, OR BY ANY INFORMATION STORAGE AND RETRIEVAL SYSTEM. WITHOUT THE WRITTEN PERMISSION OF QUICKTRIP CORPORATION, NO PART OF THIS DOCUMENT MAY BE REPRODUCED OR TRANSMITTED IN ANY FORM OR BY ANY MEANS, ELECTRONIC OR MECHANICAL, INCLUDING PHOTOCOPYING, RECORDING, OR BY ANY INFORMATION STORAGE AND RETRIEVAL SYSTEM.

No.	Revision	Date
9	ADDED SS MH	03/08/11
10	MOVED PRV IN QT'S PROPERTY	01/10/11

Bury+Partners
ENGINEERING SOLUTIONS
5510 Harvest Hill Road, Suite 100
Dallas, Texas 75230
Tel. (972)991-0011 Fax. (972)991-0278
Bury+Partners-DFW, Inc.©Copyright 2009
Texas Registration #F-1046

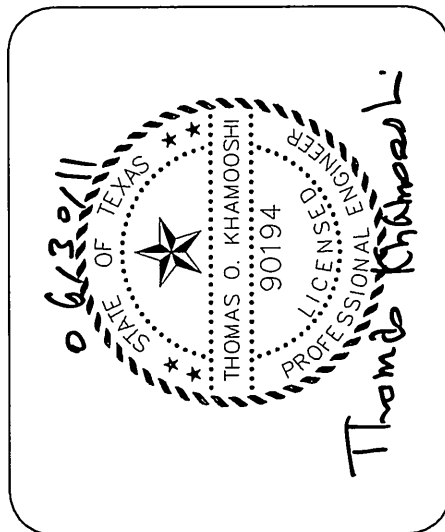

ON-SITE
SANITARY SEWER & DRY UTILITY PLAN

DRAWN BY: RGH	DESIGNED BY: TOK	CHECKED BY: TOK	ISSUE DATE: 06/04/10	SHEET 8B	OF 100
------------------	---------------------	--------------------	-------------------------	--------------------	-----------